


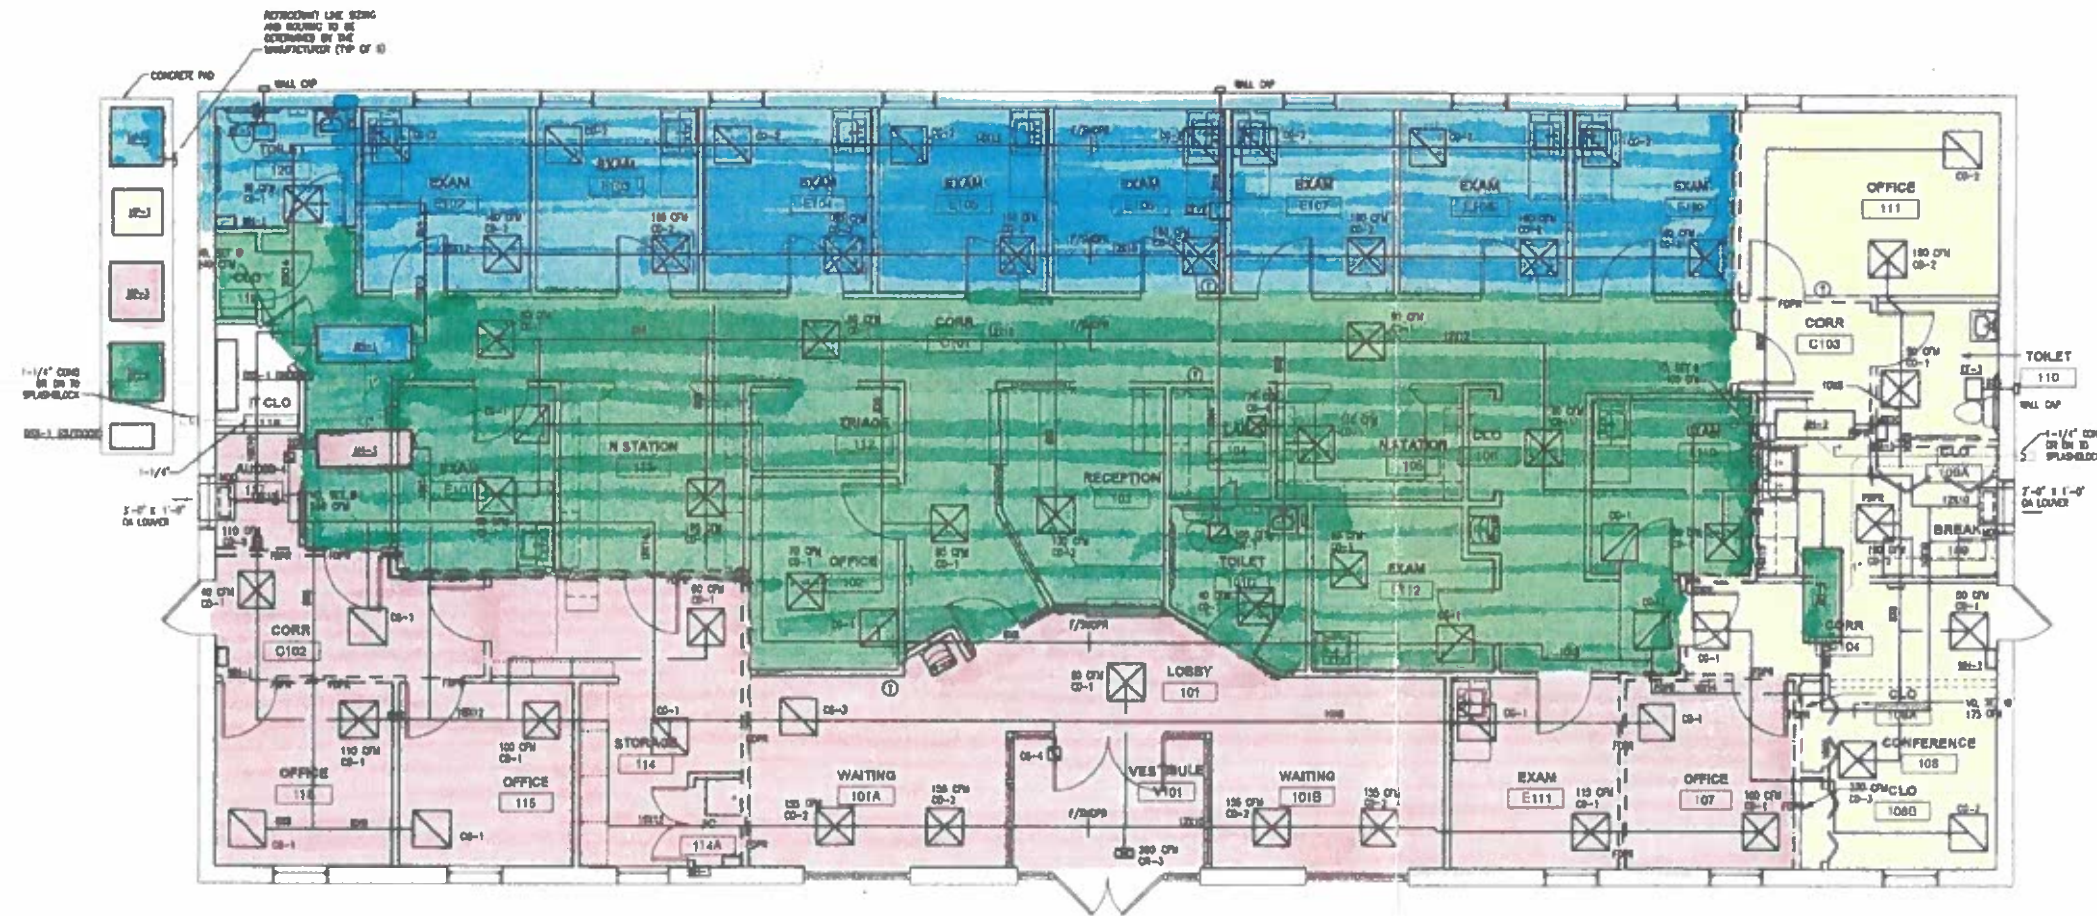

FLOOR PLAN - MECHANICAL
1/4" = 1'-0"



INTERACTIVE DESIGN GROUP
301 5TH STREET NW
ROANOKE, VA 24016
P. 540.343.7534 F. 540.342.7536



NO.	REVISIONS	DATE

REVISIONS TO:
BLACKSBURG PEDIATRICS
828 DAVIS STREET
BLACKSBURG, VA 24050

DATE	JANUARY 31 2017
DRAWN	MOR
CHECKED	MOR
JOE	1643

MECHANICAL FLOOR PLAN
SHEET
M-201